

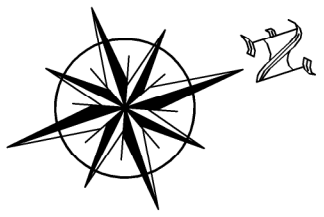


NOTES
MOLONY MILLAR CONSULTING CIVIL & STRUCTURAL ENGINEERS
THIS DRAWING AND ANY DESIGN HEREON IS THE COPYRIGHT OF THE
CONSULTANTS AND MUST NOT BE REPRODUCED WITHOUT THEIR WRITTEN
CONSENT.
ALL DRAWINGS REMAIN THE PROPERTY OF THE CONSULTANTS.
FIGURED DIMENSIONS ONLY TO BE TAKEN FROM THIS DRAWING.
ALL DIMENSIONS TO BE CHECKED ON SITE.
CONSULTANTS TO BE INFORMED OF ANY DISCREPANCIES BEFORE WORK
PROCEEDS.

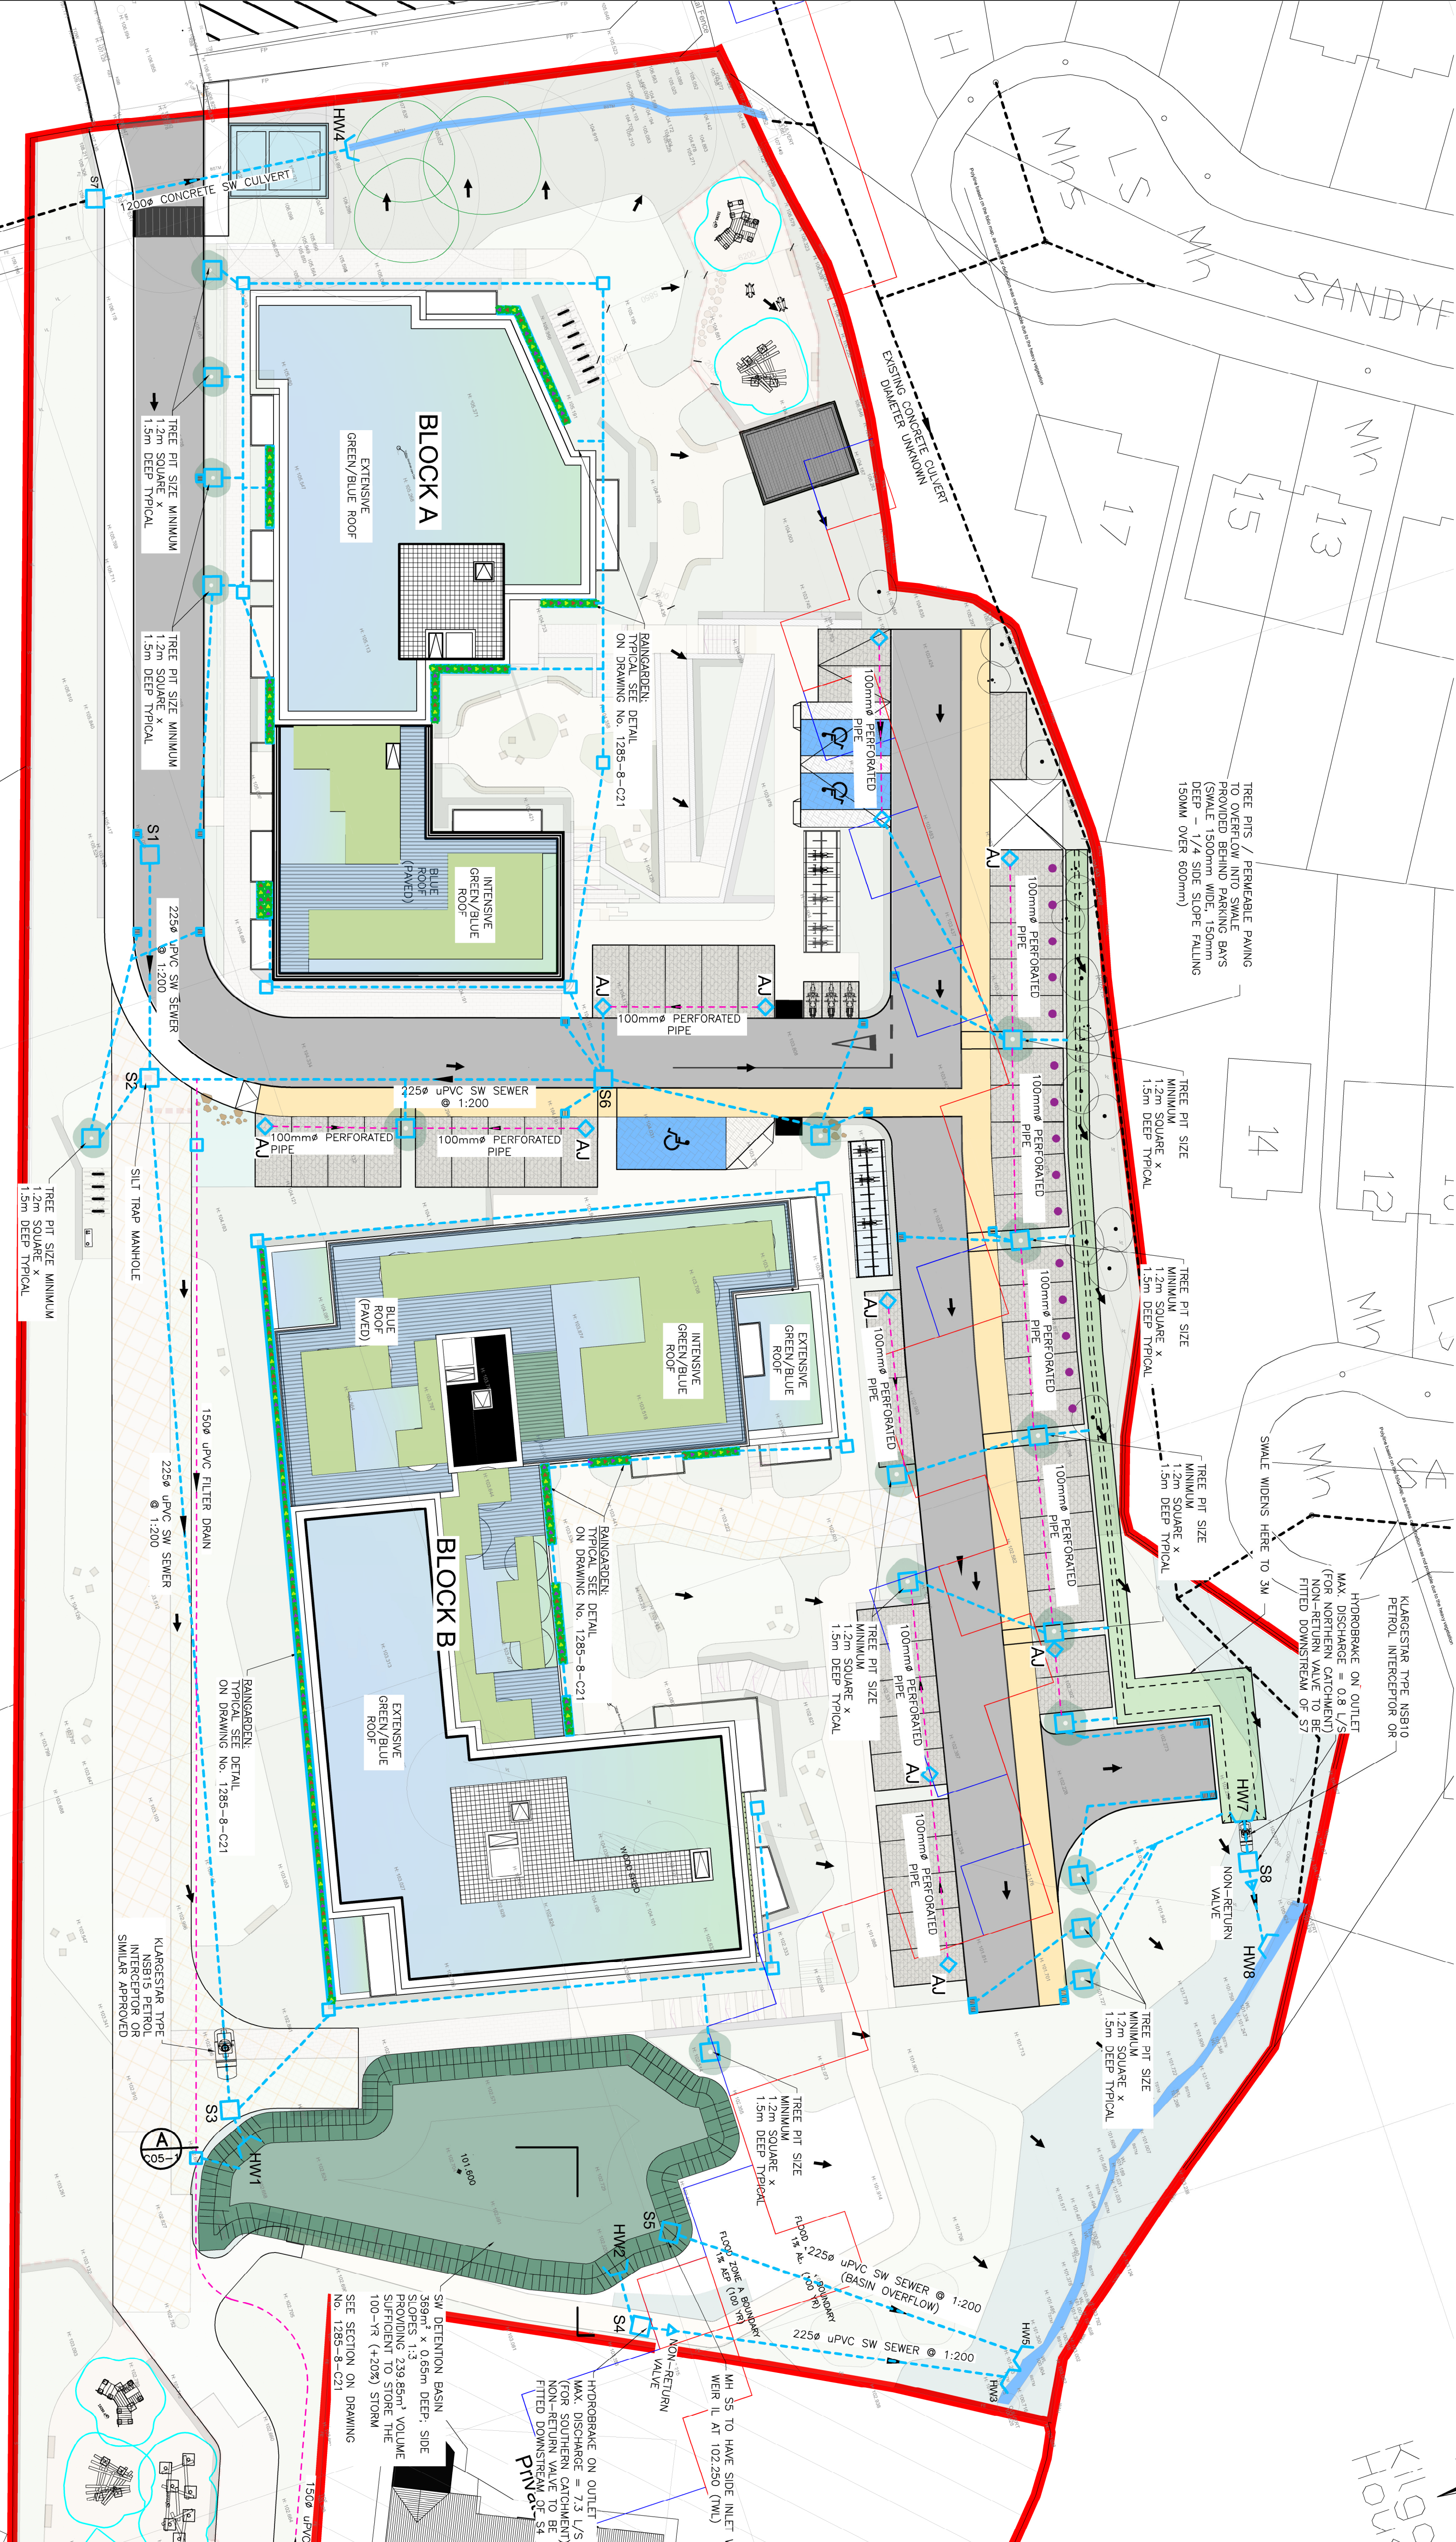

Kilgobbin
House

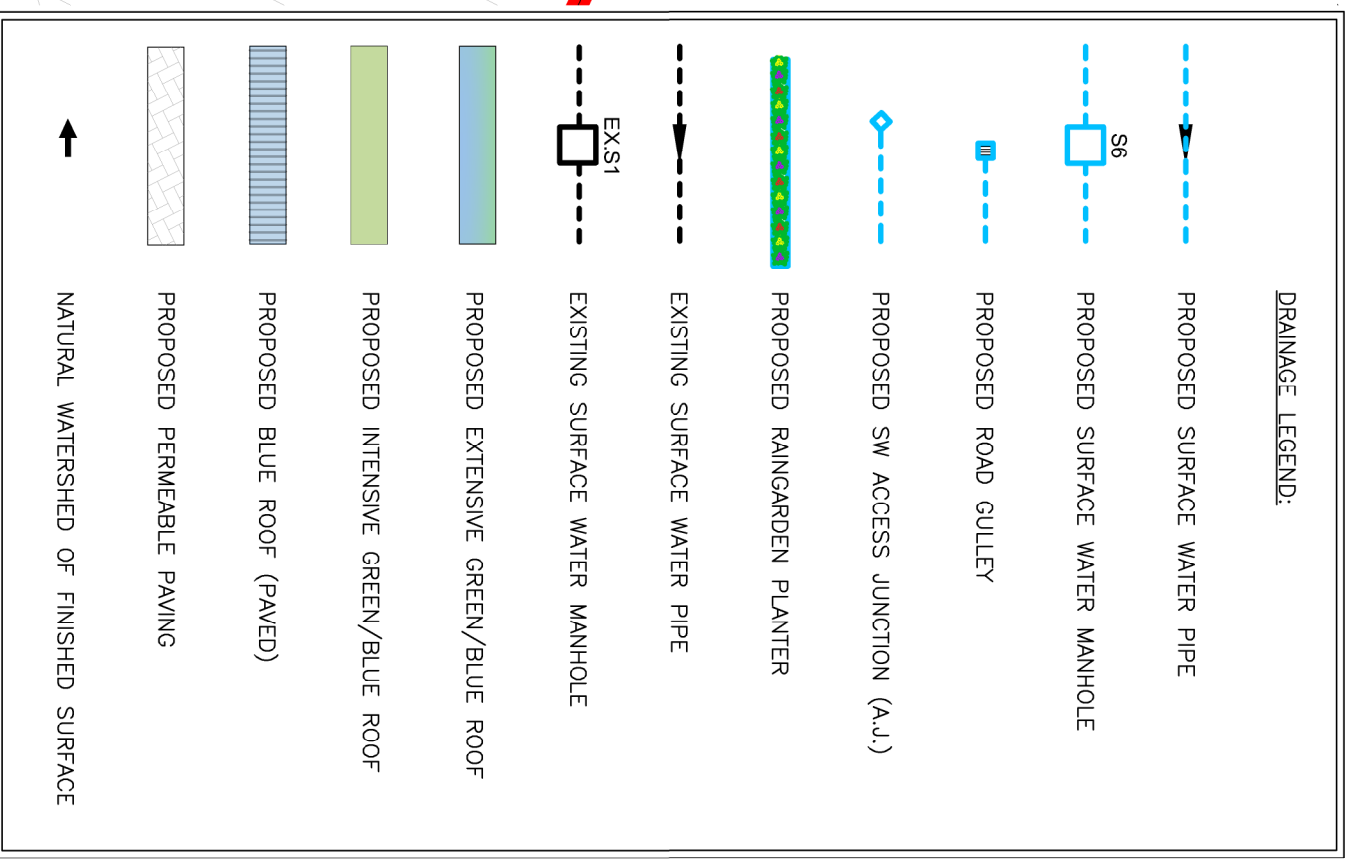

SUDS DRAINAGE LAYOUT PLAN

SCALE 1:250

Rev	Date	Description	By	Chkd

Client	KAYCO
Project Title	RESIDENTIAL DEVELOPMENT AT RIVERSIDE, KILGOBBIN ROAD, STEPPSIDE, CO DUBLIN
Drawing Title	SUDS DRAINAGE LAYOUT PLAN
Architect	MOLONY MILLAR CONSULTING CIVIL & STRUCTURAL ENGINEERS
Drawn	DOMENY
Scale	1:250 @ A1
Date	JULY 25
Drawn	C.G.
Chkd	K.G.
Job Number	1285-8
Revision	C20

Tel (353-1) 4930211
email info@molonymillar.ie
web www.molonymillar.ie
Riverside House
Ballymoran
Dublin 14
Ireland

REFER TO DRG NO. 1285-8-C05
FOR DETAILS OF THE ROOF
BUILD-UPS